


Addendum II
Questions & Answers
26-5120-01 Fire Panel Bid Q&A

1. Can the Bid Deadline be extended? The RFI are due on 11/14 and even if they are made public on 11/17 that is a narrow window to look at drawings and reports to get an accurate bid. **Extended to December 02, 2025, refer to Addendum I.**
2. Requesting Drawings of the Burnet County Jail Electronically? **Included as an attachment.**
3. Requesting the latest inspection forms of the Annual Fire Alarm Inspection? **Included as an attachment.**
4. Is other manufacture of Fire Alarm Systems allowed to be bid out? You are requesting EST4, can we bid out a Non-Proprietary system such as Silent Knight. **Yes preferred, non-proprietary.**
5. What is the estimate date of the award and projected start date? **This is going to be dependent on when the bid is due and when we can get it on the following commissioners court for approval. We hold Commissioners Court the 2nd and 4th Tuesday of every month unless there is a Holiday.**
6. Is there any Liquidated Damages on this project? **N/A, please refer to page 9 of bid packet.**
7. Is it possible to extend the window for the fire alarm contractors to estimate this project by 1 week? **Extended to December 02, 2025, refer to Addendum I.**
8. Can you provide fire alarm and mechanical plans for the facility? **Included as an attachment.**

REVISION:	DATE
INITIAL DESIGN:	04/04/08
REV 1:	
REV 2:	
REV 3:	
JOB NO:	83-00113
PROJ. MGR:	P. HARP
CHECKED BY:	W. MUELLER
DRAWN BY:	A. RANKIN
DATE:	04/28/08

DWG TITLE:	FIRE ALARM LAYOUT
DWG NO:	FA2.01
SHEET NO:	2 OF 3

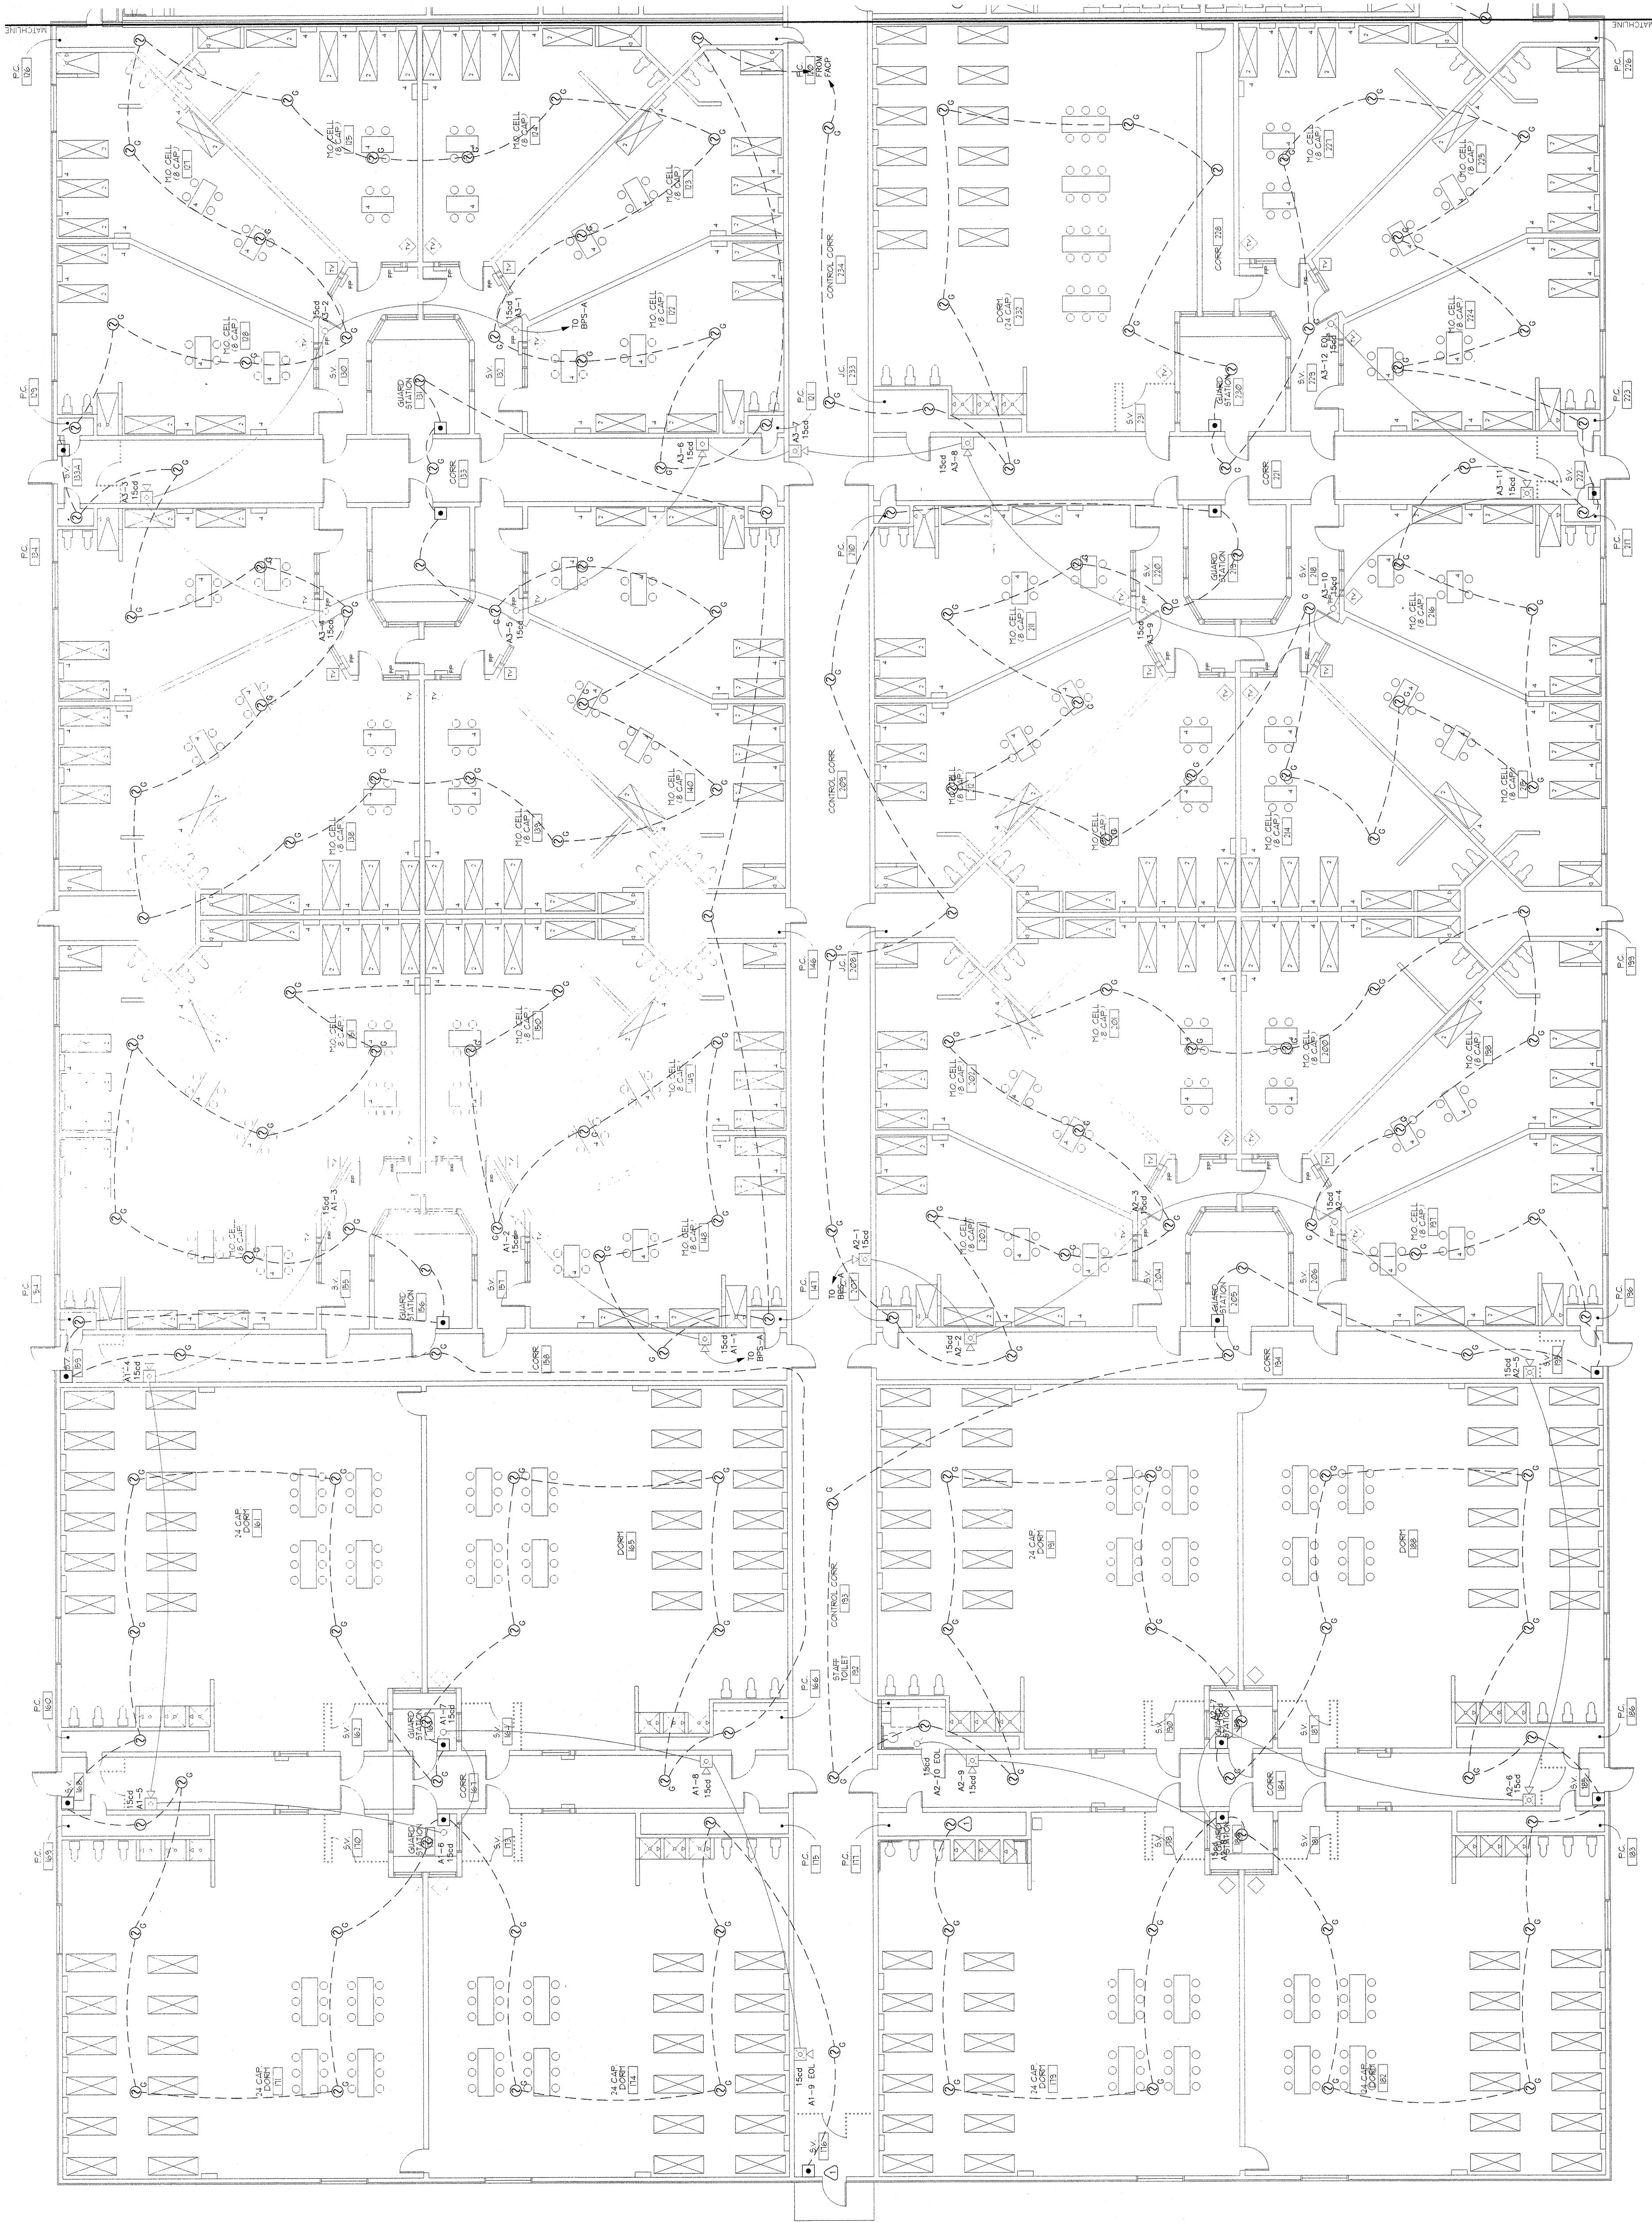

1 FIRE ALARM LAYOUT
SCALE: 1/32"=1'-0"



☐ FOR SUBMITTAL ☐ RECORD DRAWINGS
I have reviewed these plans and
specifications and certify that they
comply with the applicable code
and standards.
Or
I, the undersigned, being a duly
licensed professional engineer,
and any violation of the applicable code or standards
are specifically noted on these plans.
Metroplex Control Systems, Inc.
San Antonio, TX 78247
(210) 485-5245 ACR-2585-C
APES License # License #
WILLIAM D. MUELLER
APES Printed Here Date

BURNET COUNTY DETENTION
900 ELLEN HALBERT DR.
BURNET, TEXAS 78611

REVISION:	DATE:
INITIAL DESIGN:	04/04/08
REV 1:	
REV 2:	
REV 3:	
JOB NO:	83-00113
PROJ. MGR:	P. HARP
CHECKED BY:	W. MUELLER
DRAWN BY:	A. RANKIN
DATE:	04/28/08

DWG TITLE:	FIRE ALARM LAYOUT
DWG NO:	FA2.02
SHEET NO:	3 OF 3

☐ FOR SUBMITTAL ☐ RECORD DRAWINGS
I have reviewed these plans and
certify that they comply with the applicable codes
and standards.
Or
I have reviewed these plans and
certify that they were created from existing, approved plans
and any revision of the applicable codes or standards
are specifically noted on these plans.
Metropolitan Control Systems, Inc.
San Antonio, TX 78247
(210) 455-5245 ACR-2585-C
APIS Licensee Signature - License #
WILLIAM D. MUELLER
APIS Printout Name

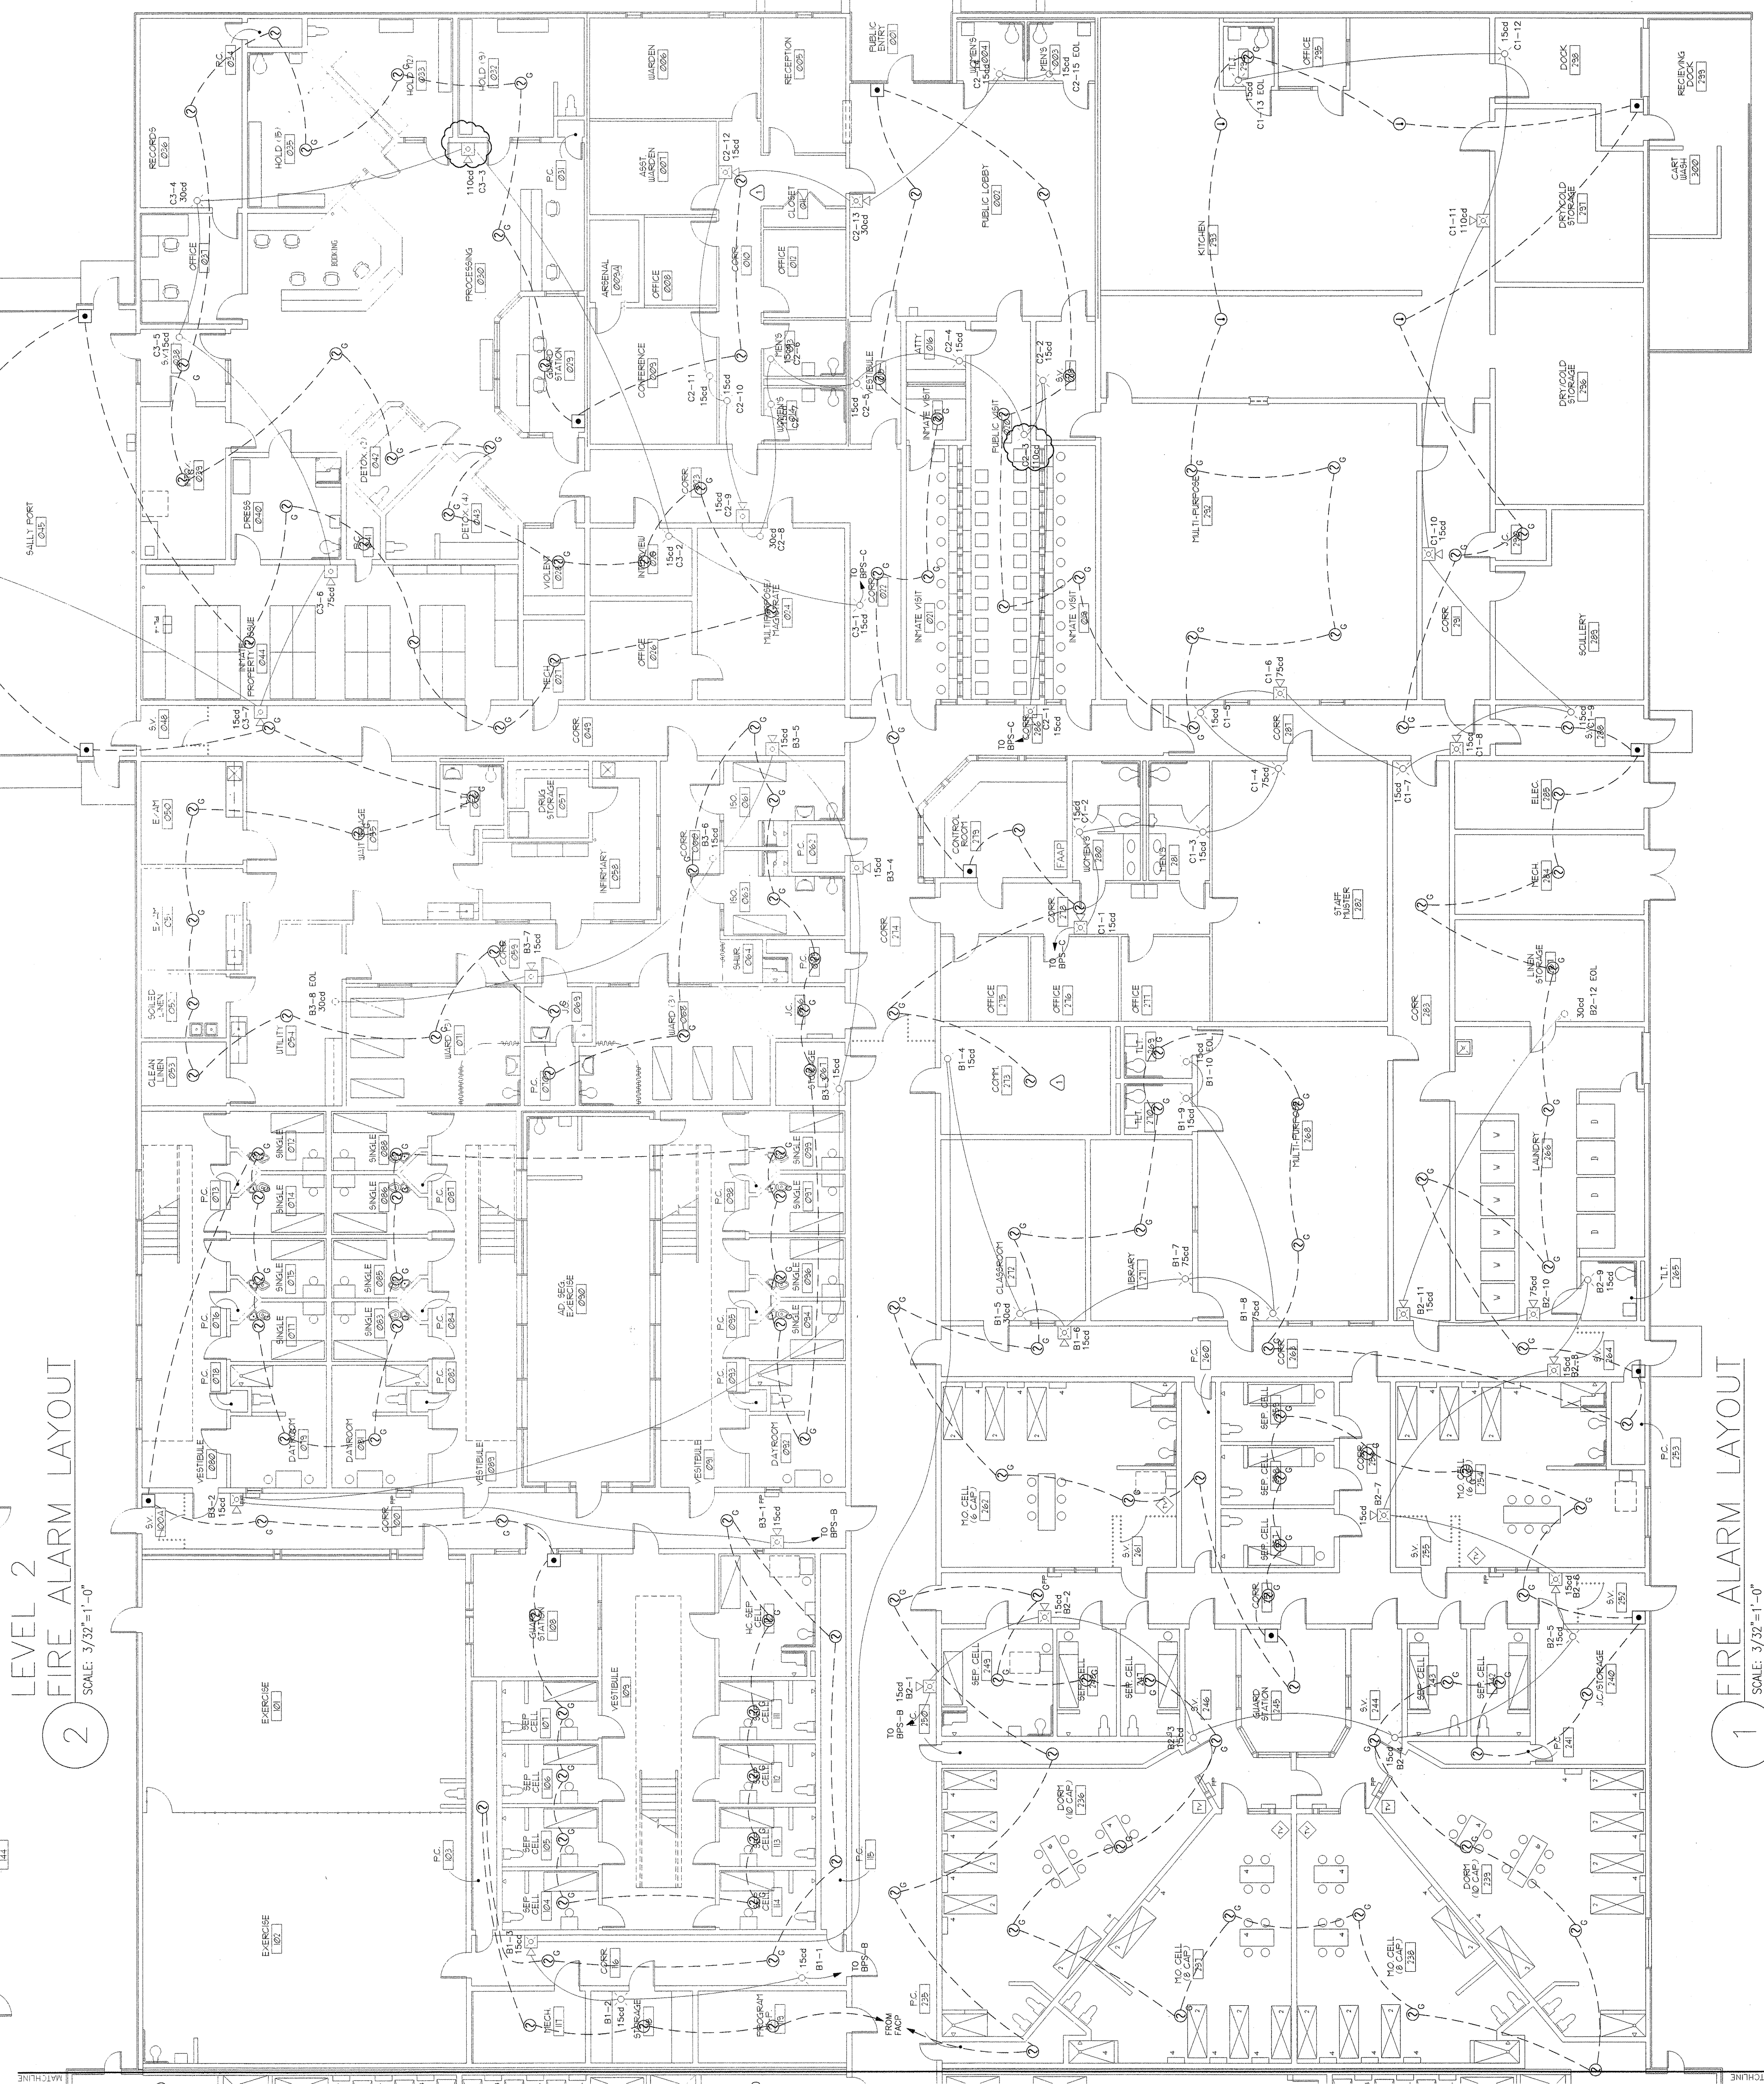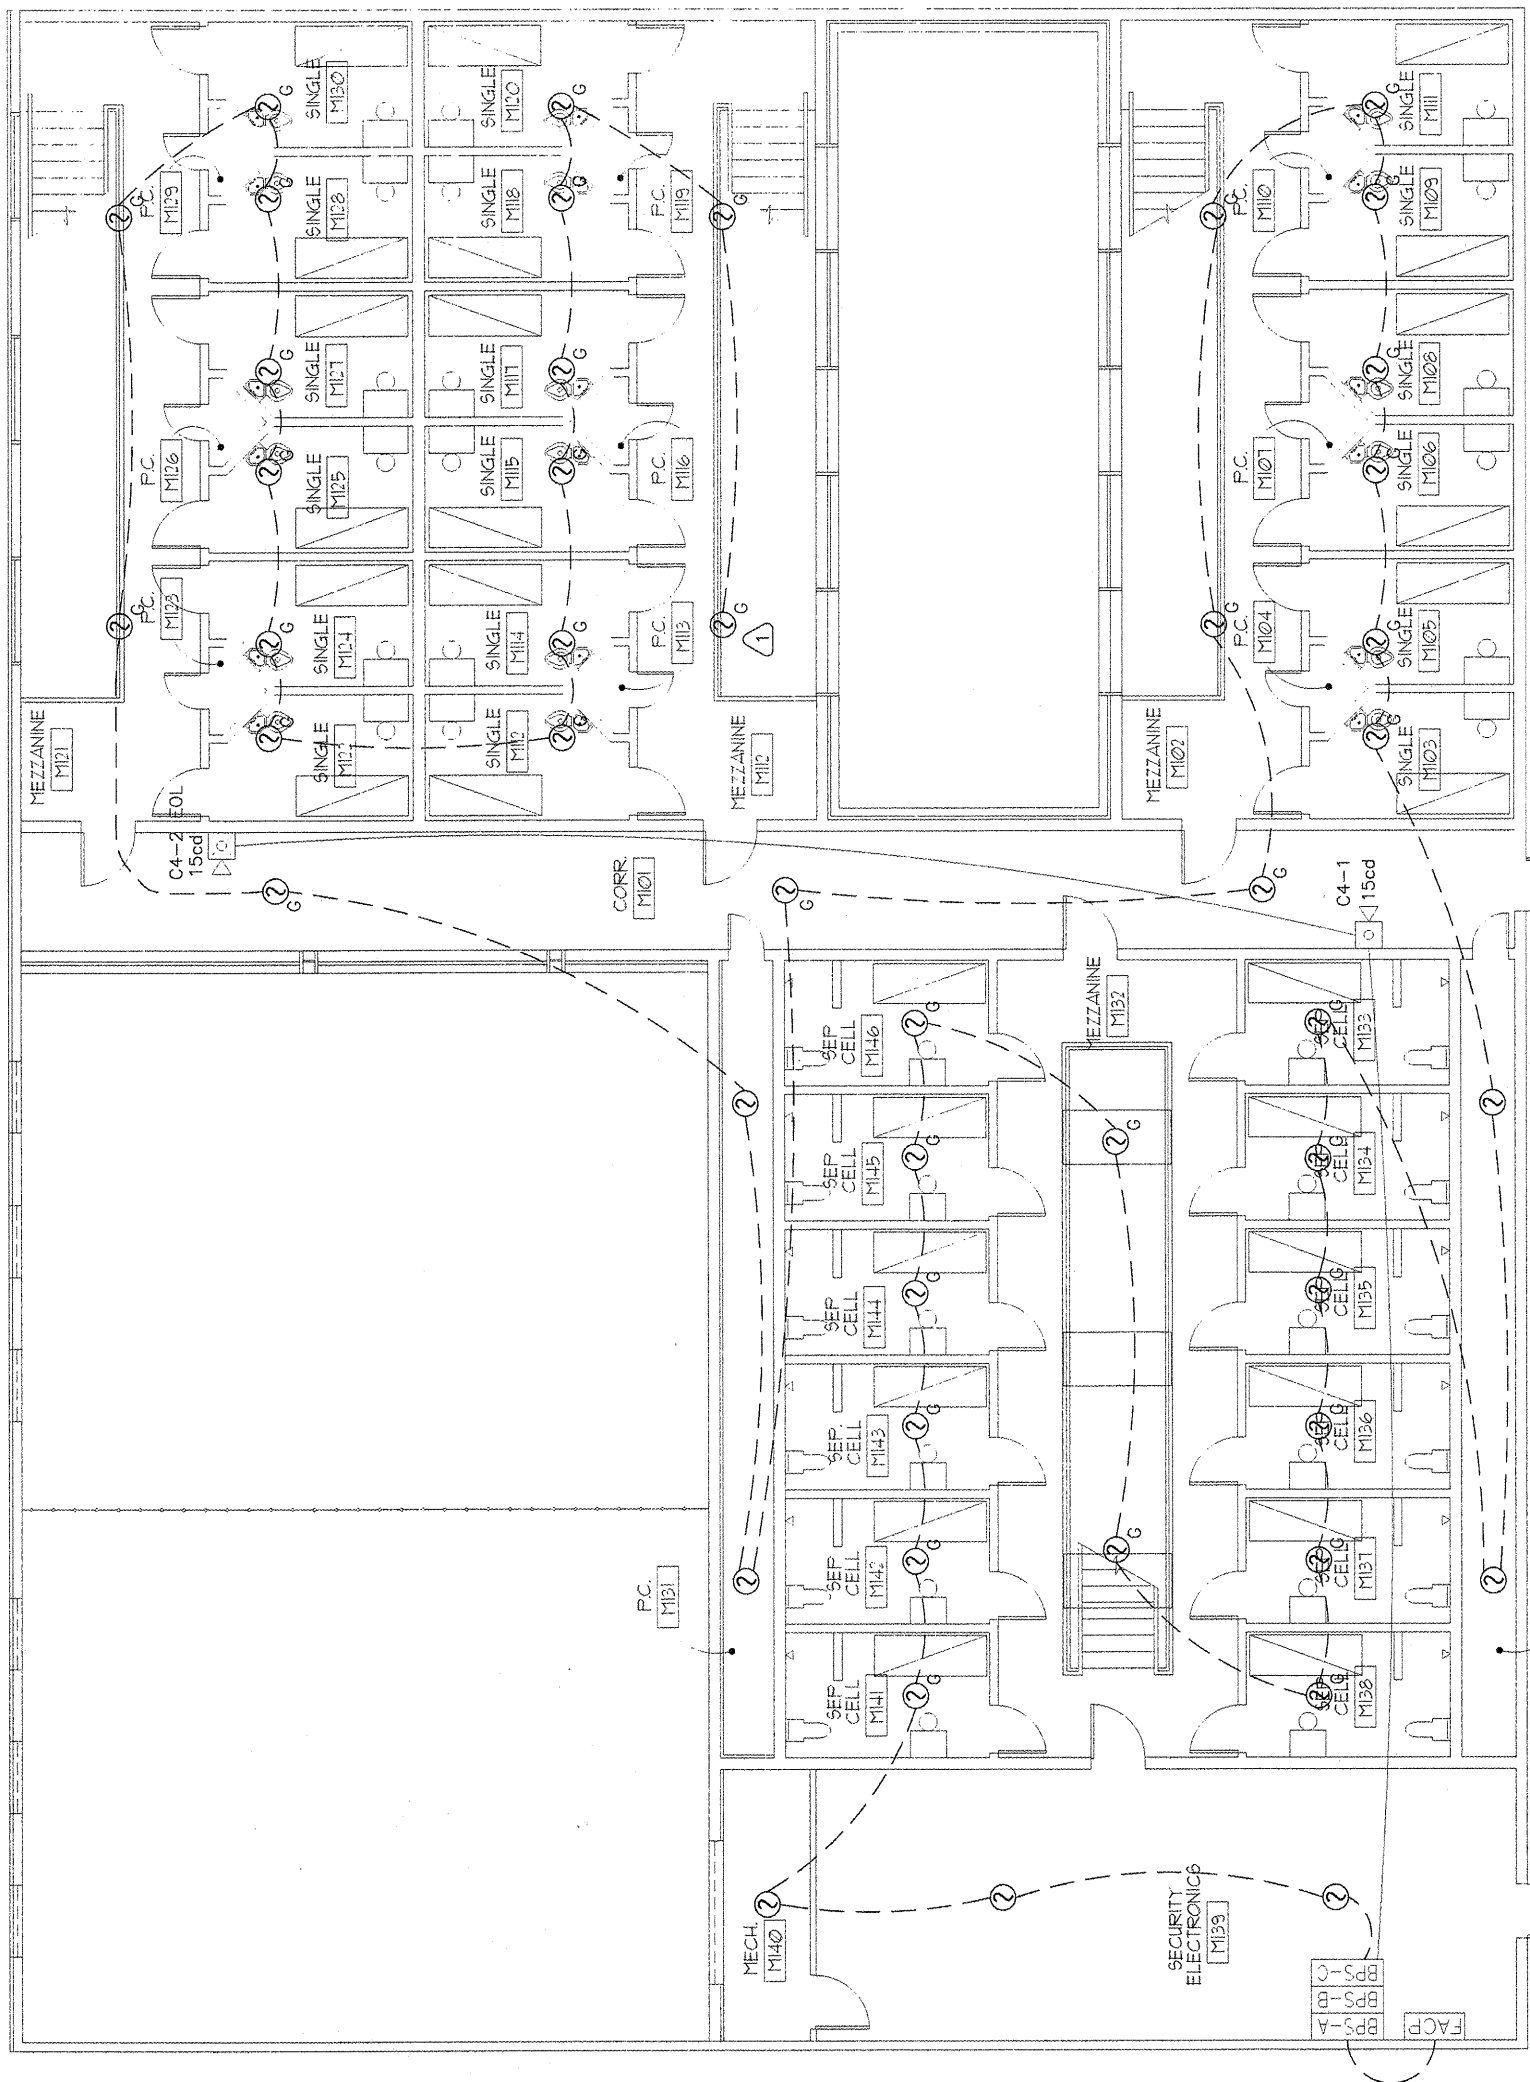

**10418 GULFDALE
SAN ANTONIO, TEXAS 78216
TEL: (210) 348-7850
FAX: (210) 386-0847**

BOX 3340
AMARILLO, TEXAS 79116

FAX 806 - 373 0707
TEL 806 - 372 5665

BURNET, TEXAS

©COPYRIGHT 2008
ANY REPRODUCTION, POSSESSION,
OR USE OF THESE PLANS OR ANY
PART THEREOF WITHOUT THE WRITTEN
PERMISSION OF DRG ARCHITECTS,
LLC IS PROHIBITED AND WILL BE
PROSECUTED TO THE FULL EXTENT

PROJECT NO: 2750
DATE: FEB 2008

OVERALL LIGHTING FLOOR PLAN

E2.00

GENERAL NOTES:

- A. ALL 277V BRANCH CIRCUITS OVER 225 FT. SHALL BE #10 THIN FULL LENGTH, OVER 425 FT. SHALL BE #8 THIN
- B. ALL CONDUITS WILL HAVE A SEPARATE INSULATED GREEN GROUNDING CONDUCTOR SIZED BY THE LOAD
- C. CONDUIT RUNS SHOWN ARE DIAGRAMMATIC IN NATURE. CONTRACTOR IS RESPONSIBLE FOR SIZING AND LOCATING PULL BOXES PER NEC AND COORDINATION WITH OTHER TRADES.
- D. ALL DEVICE PLATES IN INMATE OCCUPIED AREAS WILL HAVE "FIRE RESISTANT TORX REJECTION SCREWS" DEVICE PLATES WILL BE STAINLESS STEEL PLATES.


1 MOUNT LIGHTING ABOVE SECURITY MESH AND BELOW HVAC DUCT AT SECURITY VESTIBULES LEADING INTO M.O. CELLS.

2 RLZ RELAY PANEL AT ELECTRICAL 289.


3 TWO HUBBELL LXS60P SWITCH STATIONS OR EQUAL. MOUNT SWITCHES IN GUARD STATIONS 131, 142, 356 AND 210 CABINET TOP NEXT TO SECURITY ELECTRONICS TOUCH SCREEN. LABEL SWITCHES FOR LIGHTING OUTLETS AS PER ROOM NUMBERS.

4 TWO HUBBELL LXS60P SWITCH STATIONS OR EQUAL. MOUNT SWITCHES IN GUARD STATIONS 166, 172, 188 AND 189 CABINET TOP NEXT TO SECURITY ELECTRONICS TOUCH SCREEN. LABEL SWITCHES FOR LIGHTING AND OUTLETS AS PER ROOM NUMBERS.

1. MOUNT LIGHTING ABOVE SECURITY MESH AND BELOW HVAC DUCT AT SECURITY VESTIBULES
2. LEADING INTO M.O. CELLS
3. RZ RELAY PANEL AT ELECTRICAL 289
4. TWO HUBBLE LSWX/LP AND ONE LSWX/LP MOUNT SWITCHES IN GUARD STATIONS 133, 143, 156, 205 AND 219 CABINET TOP NEXT TO SECURITY ELECTRONICS TOUCH SCREEN LABEL SWITCHES FOR LIGHTING AND OUTLETS AS PER ROOM NUMBERS.
5. ONE HUBBLE LSWX/LP SWITCH STATION OR EQUAL. MOUNT SWITCHES IN GUARD STATIONS 163, 172, 180 AND 189 CABINET TOP NEXT TO SECURITY ELECTRONICS TOUCH SCREEN LABEL SWITCHES FOR LIGHTING AND OUTLETS AS PER ROOM NUMBERS.
6. CABINET TOP NEXT TO SECURITY ELECTRONICS TOUCH SCREEN LABEL SWITCHES FOR LIGHTING AND OUTLETS PER ROOM NUMBERS.
7. TWO HUBBLE LSWX/LP AND ONE LSWX/LP SWITCH STATIONS OR EQUAL. MOUNT SWITCHES IN GUARD STATION 108 CABINET TOP NEXT TO SECURITY ELECTRONICS TOUCH SCREEN LABEL SWITCHES FOR LIGHTING AND OUTLETS AS PER ROOM NUMBERS.
8. TWO HUBBLE LSWX/LP AND ONE LSWX/LP SWITCH STATIONS OR EQUAL. MOUNT SWITCHES IN GUARD STATION 029 CABINET TOP NEXT TO SECURITY ELECTRONICS TOUCH SCREEN LABEL SWITCHES FOR LIGHTING AS PER ROOM NUMBERS.
9. TWO HUBBLE LSWX/LP AND ONE LSWX/LP SWITCH STATIONS OR EQUAL. MOUNT SWITCHES IN GUARD STATION 029 CABINET TOP NEXT TO SECURITY ELECTRONICS TOUCH SCREEN LABEL SWITCHES FOR LIGHTING AS PER ROOM NUMBERS.

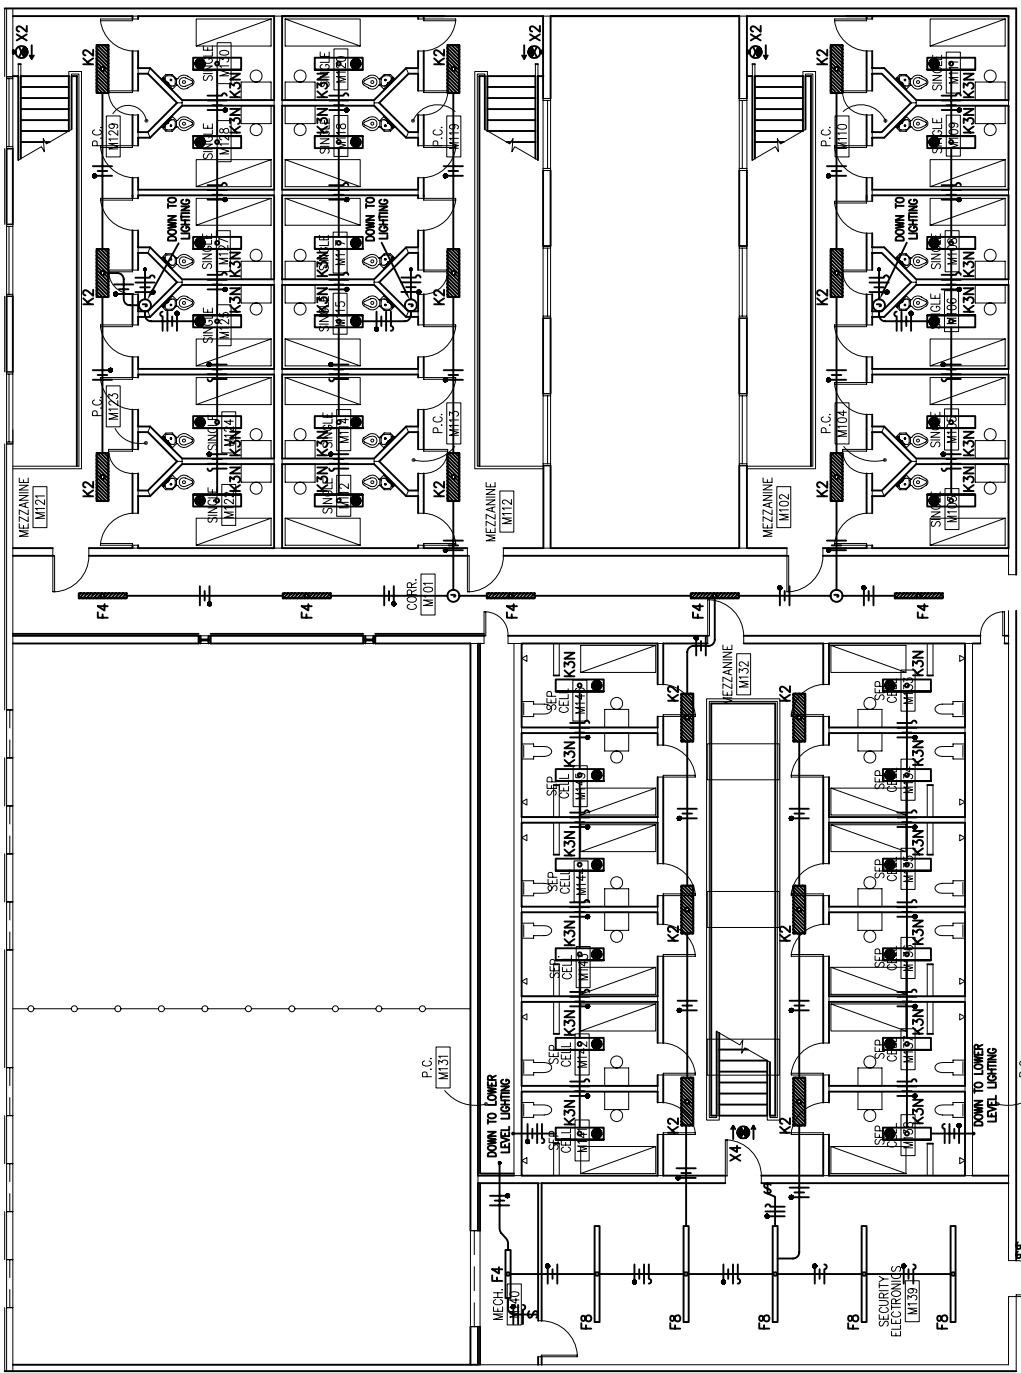

MEZZANIN
SCALE: 1/16" = 1'-0"
E2.00
2

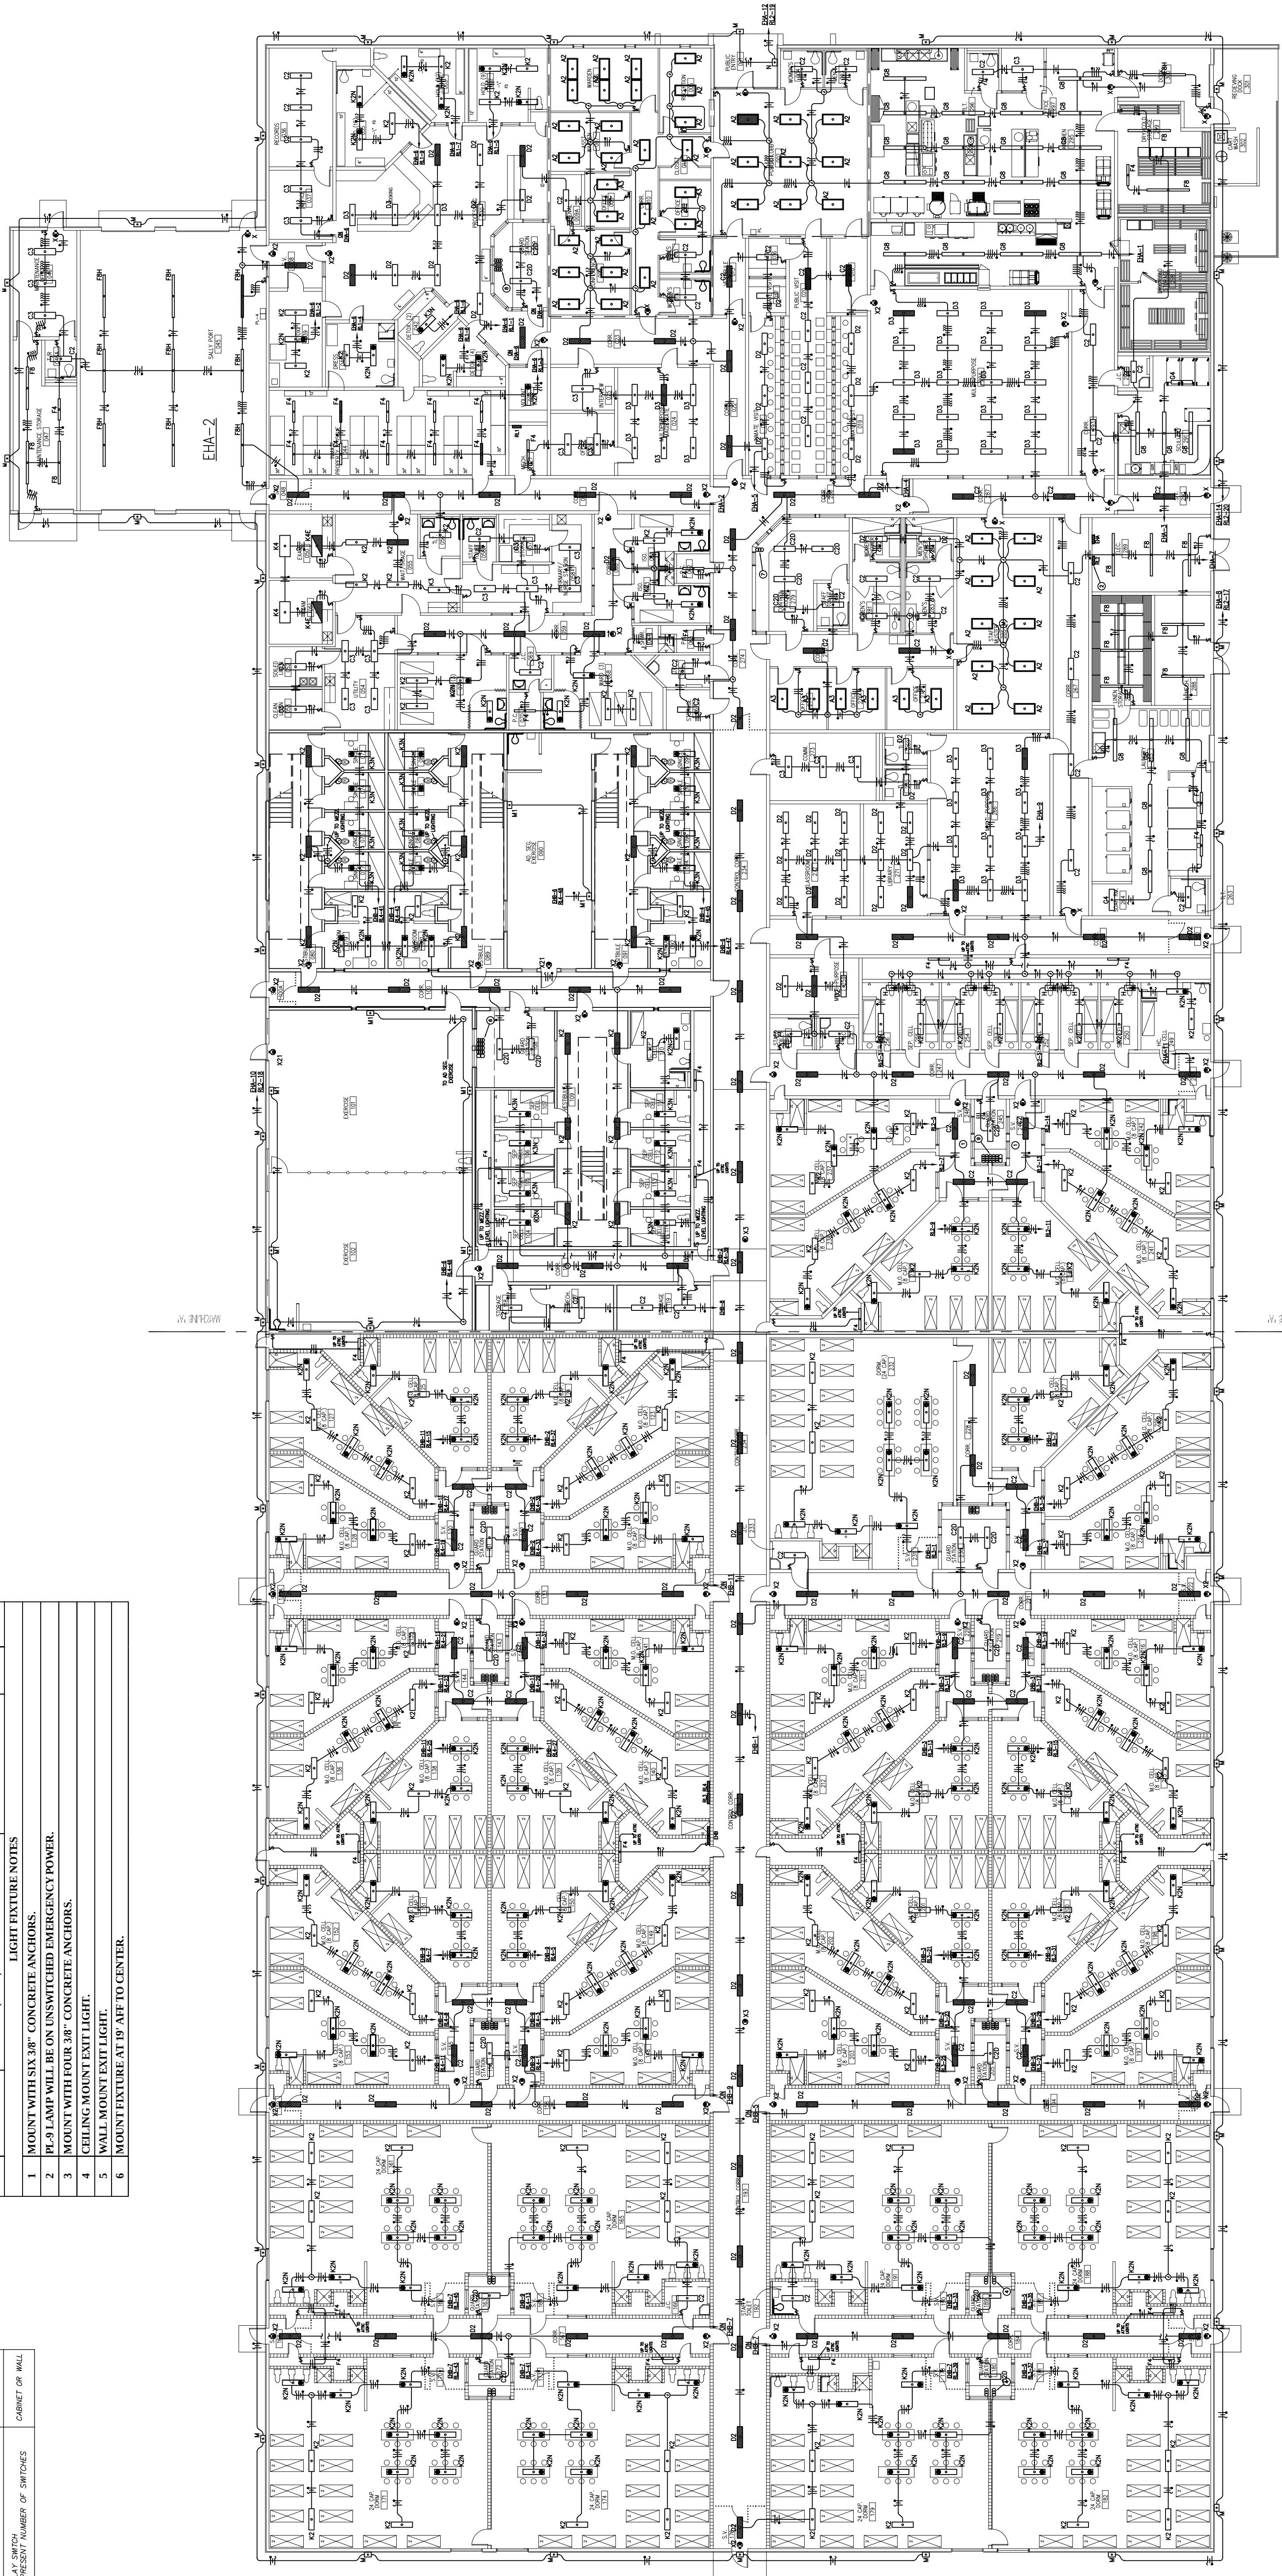[illegible][illegible]

1 OVERALL LIGHTING FLOOR PLAN

E2.00 SCALE: 1/16" = 1'-0"
2/20

E2.00 SCALE: 1/16" = 1'-0"
2750

**DO NOT REMOVE BY ORDER OF
TEXAS STATE FIRE MARSHAL**

(for at least two years)

SERVICE RECORD

Star Assrt Security, LLC
12500 Network BLVD STE 402
San Antonio, Texas 78249

(888) 215-0987

ACR - 1703885

5/22/25

[Signature]

APS-2999239

Date

Licensee Signature

License #

List Services: *Deactivated switch for
In 3 off. Changed network
to Class A in program*

Performed ☒ General service listed above

Corrected ☐ RED label dated _____

Corrected ☐ YELLOW label dated _____

Corrected ☐ RED label dated _____
Corrected ☐ YELLOW label dated _____

Corrected ☐ YELLOW label dated _____

Corrected ☐ RED label dated _____
Corrected ☐ YELLOW label dated _____

01/21/21 *[Signature]* #39151

List Services: *put 1 card 02, Map Point*

did a stroke & change. [unclear]

Performed ☒ General service listed above

Corrected ☐ RED label dated _____

Corrected ☐ YELLOW label dated _____

TAF
SECURITY

and Life Safety & Security

01.1616

DO NOT REMOVE BY ORDER OF
TEXAS STATE FIRE MARSHAL
(for at least five years)

INSPECTION RECORD

Star Asset Security, LLC
34 Freedom Ct., STE E, Greer, SC 296500
877-801-1616 - ACR1703885

1-16-25 *[Signature]* *FAL-2010063*
Date Licensee Signature License #

Type of Inspection/Test Performed - NFPA 72

- ☐ New Installation ☐ Quarterly
☐ Semi Annual ☒ Annual

Last Date of Sensitivity Test, if known _____
Status After Inspection/Test

- ☒ Acceptable ☐ Yellow Label ☐ Red Label
(attached) (attached)

(attached) (attached)

877.801.1616
www.securethinking.com
ACR-1703885 & B17053

24 Hour Monitor